
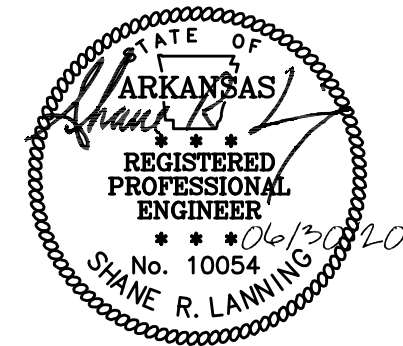


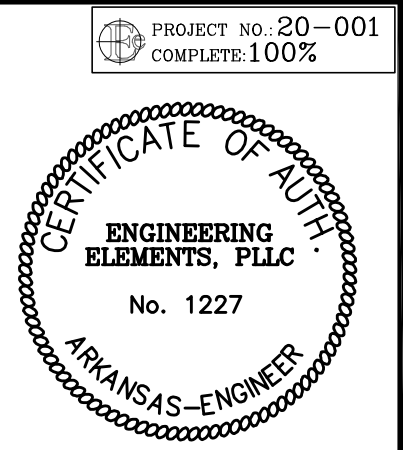

FOREMAN SCHOOL DISTRICT
NEW HIGH SCHOOL
FOREMAN, ARKANSAS

ARCHITECTURE PLUS, INC.
907 South 21st Street Fort Smith, Arkansas 479-783-8395

Engineering Elements, PLLC
2458 East Joyce Boulevard, Suite 1, Fayetteville, AR 72703
Phone: 479-695-1333


OVERALL ACCESS CONTROL PLAN

REVISIONS:	

PROJECT: 19-21
DATE: 06-30-20

AC1.1

ARCHITECTS • PLANNERS

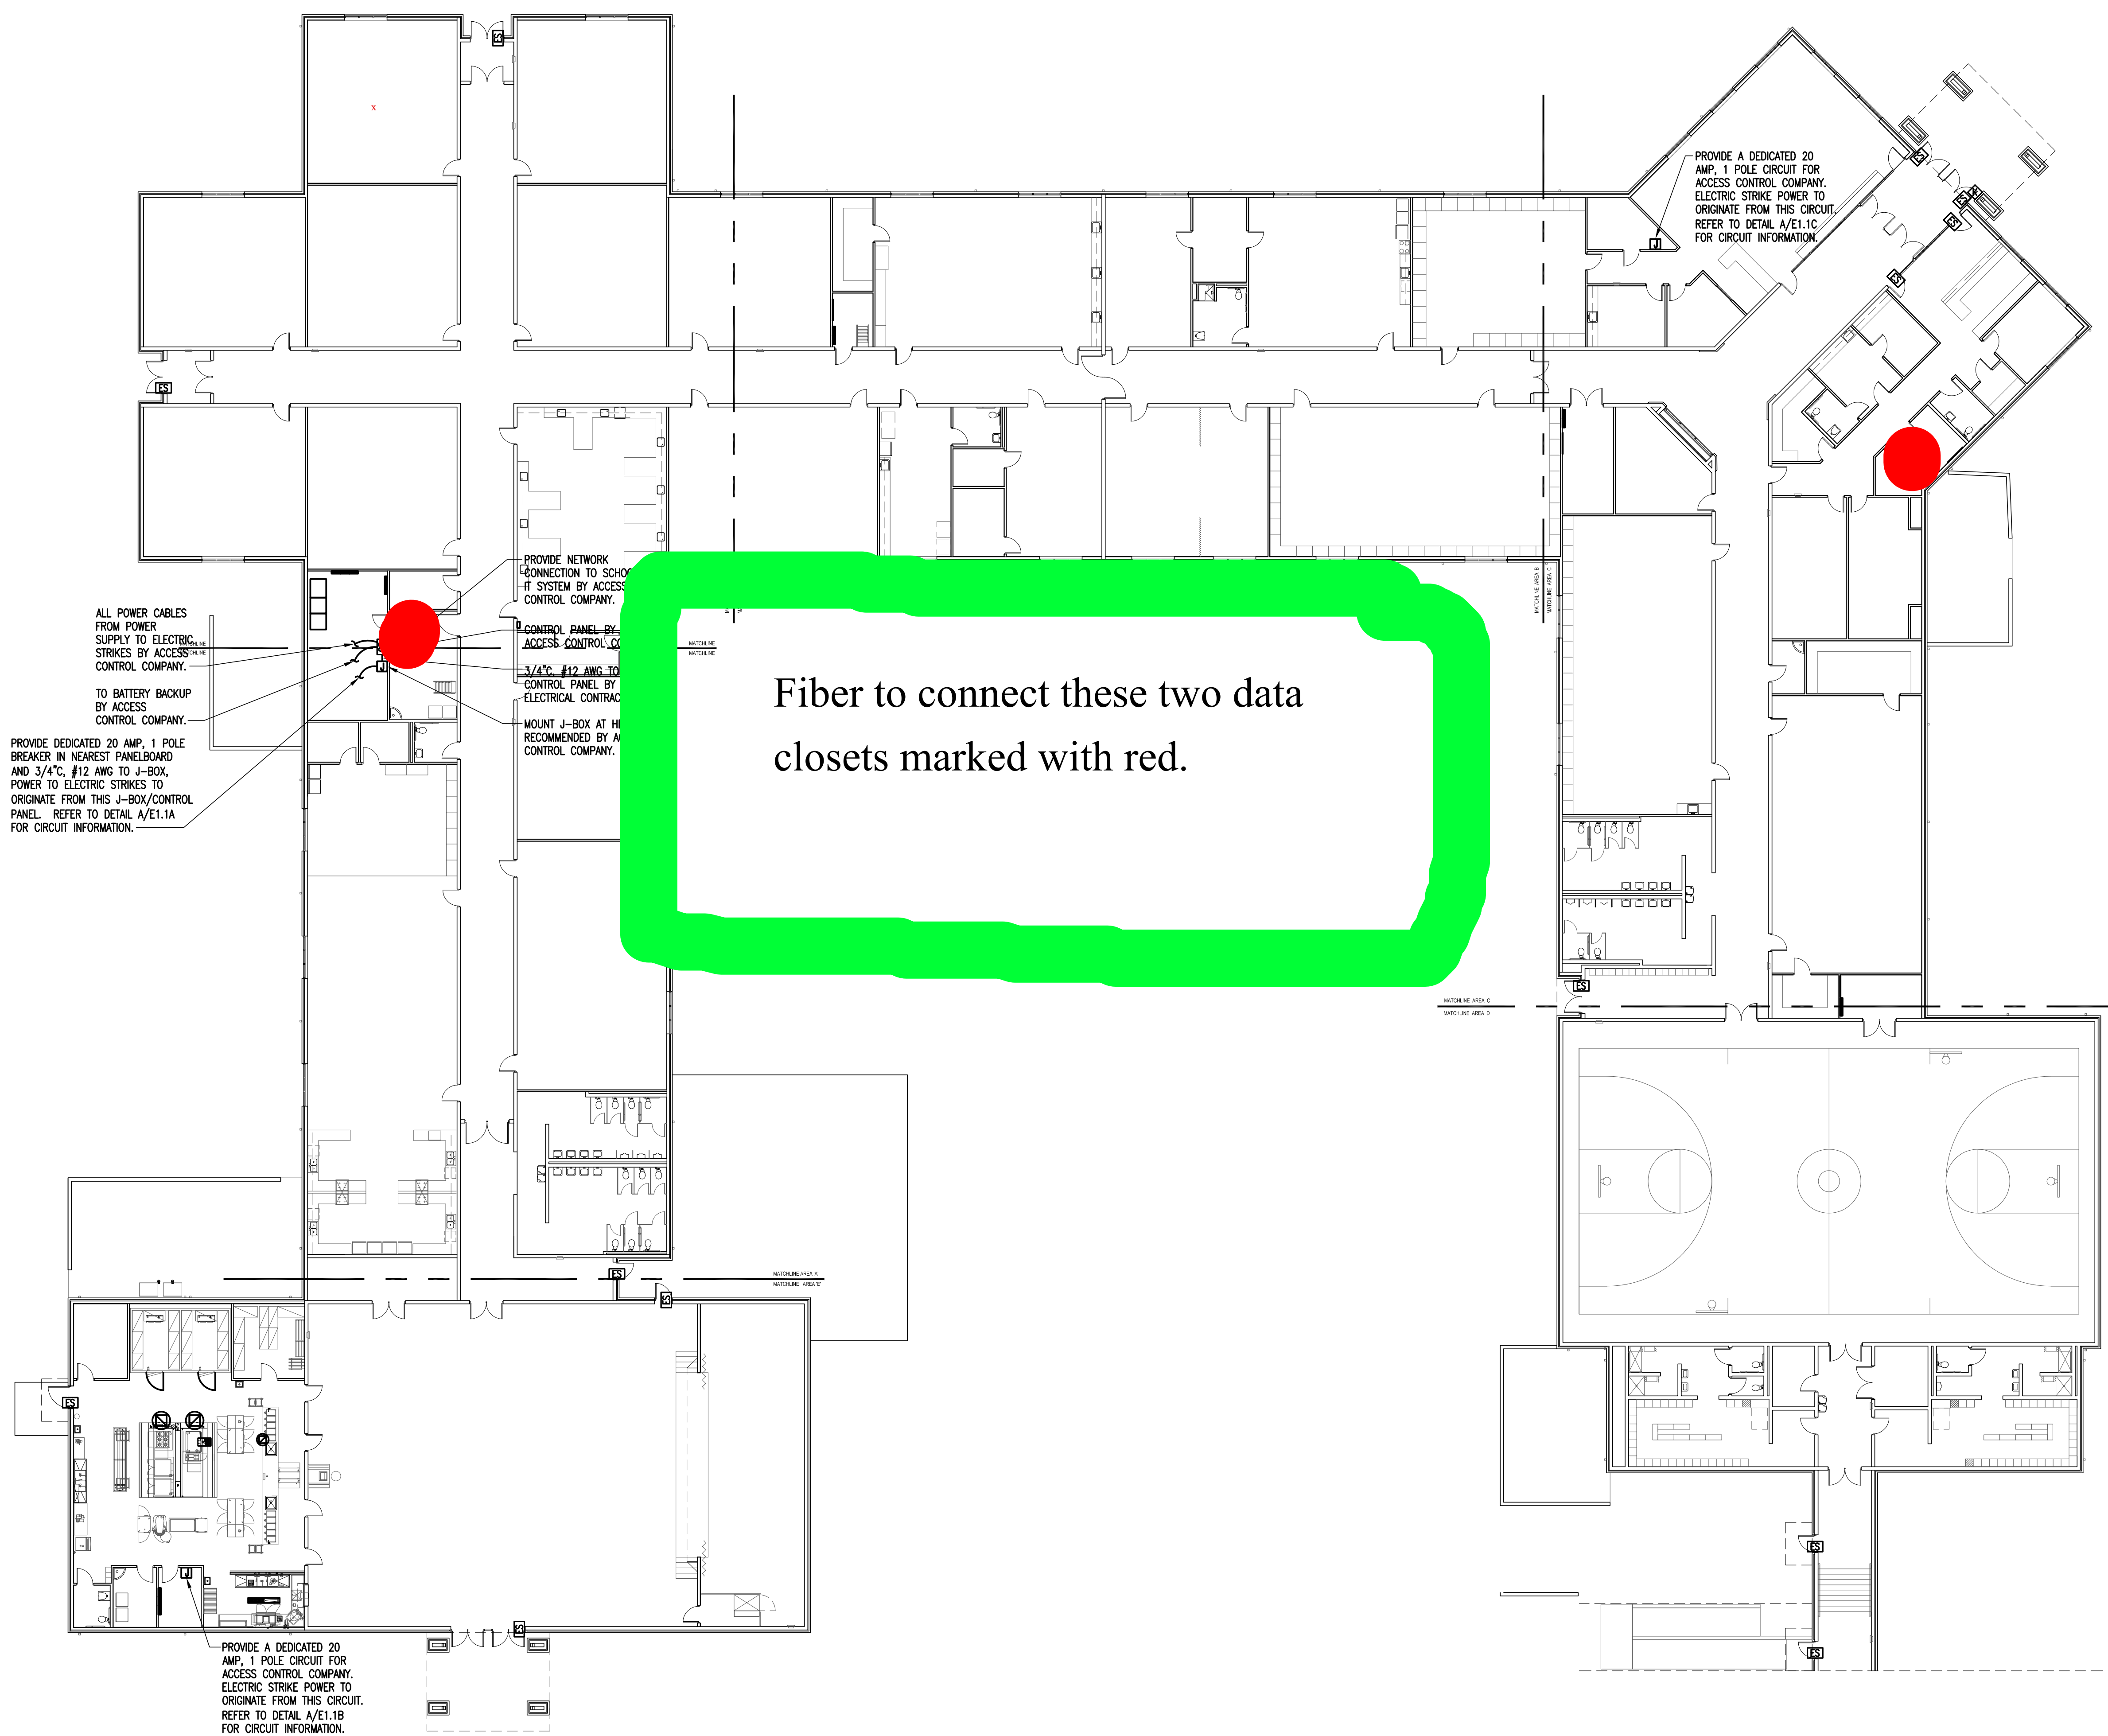

ELECTRICAL LEGEND			
[JB]	JUNCTION BOX	[ACP]	ACCESS CONTROL PANEL
[AK]	ACCESS CONTROL KEYPAD, PROVIDE 1" CONDUIT TO ACCESSIBLE CEILING SPACE	[ES]	ELECTRIC STRIKE, PROVIDE 1" CONDUIT TO ACCESSIBLE CEILING SPACE

NOTES:
1. ALL LISTED MOUNTING HEIGHTS ARE TO THE CENTER OF THE DEVICE.

A OVERALL ACCESS CONTROL PLAN
SCALE: 1/16" = 1'-0"