


FOREMAN SCHOOL DISTRICT  
NEW HIGH SCHOOL  
FOREMAN, ARKANSAS

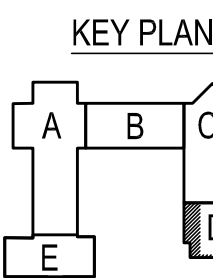

ARCHITECTURE PLUS, INC.  
907 South 21st Street Fort Smith, Arkansas 479-783-8395

Engineering Elements, PLLC  
2458 East Joyce Boulevard, Suite 1, Fayetteville, AR 72703  
Phone: 479-695-1333

ELECTRICAL POWER PLAN - AREA 'D'

REVISIONS:


PROJECT: 19-21

DATE: 06-30-20

E1.1D



ARCHITECTS · PLANNERS

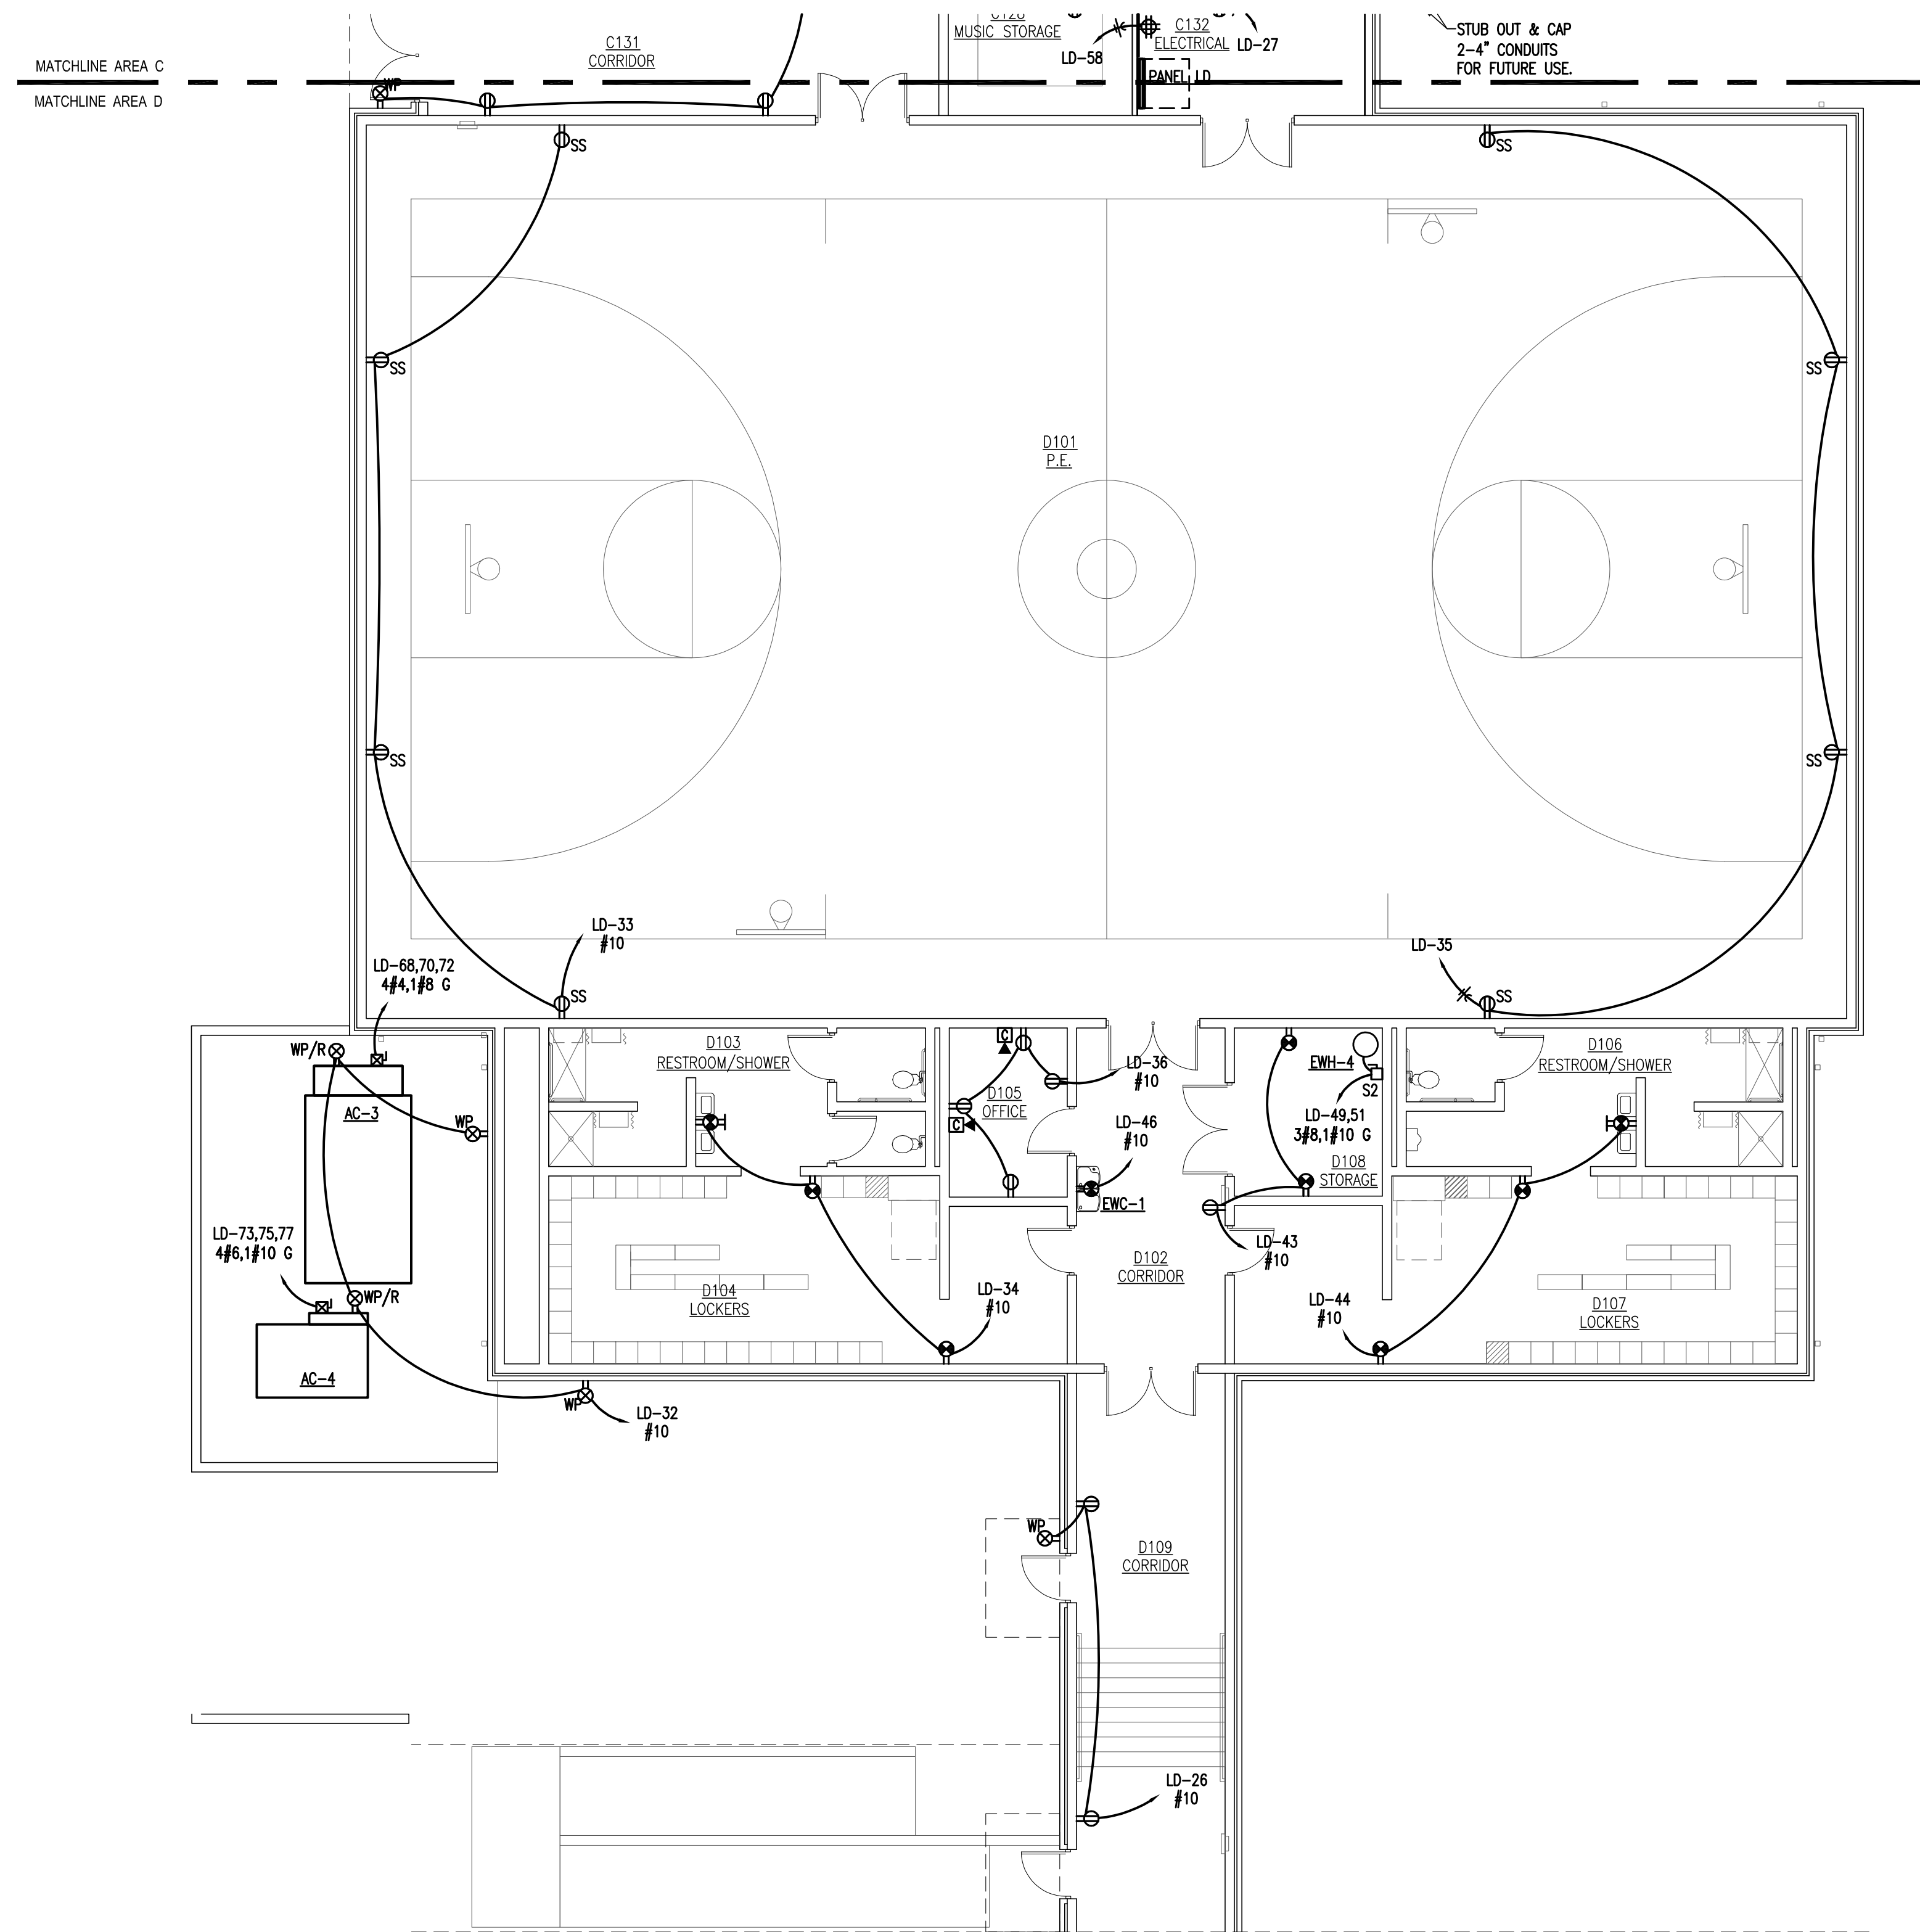

A ELECTRICAL POWER PLAN - AREA 'D'  
SCALE: 1/8" = 1'-0"